


D-1010
 KNOCK- OUT DRUM
 Vnom 4 m3
 od 1200 mm
 TL-TL 2700 mm
 pe * 40 bar
 t * 80
 * = MECH.DESIGN

REMARKS:
 1- LENGHT APPR. 1400 mm
 2- HEIGHT APPR. 1400 mm

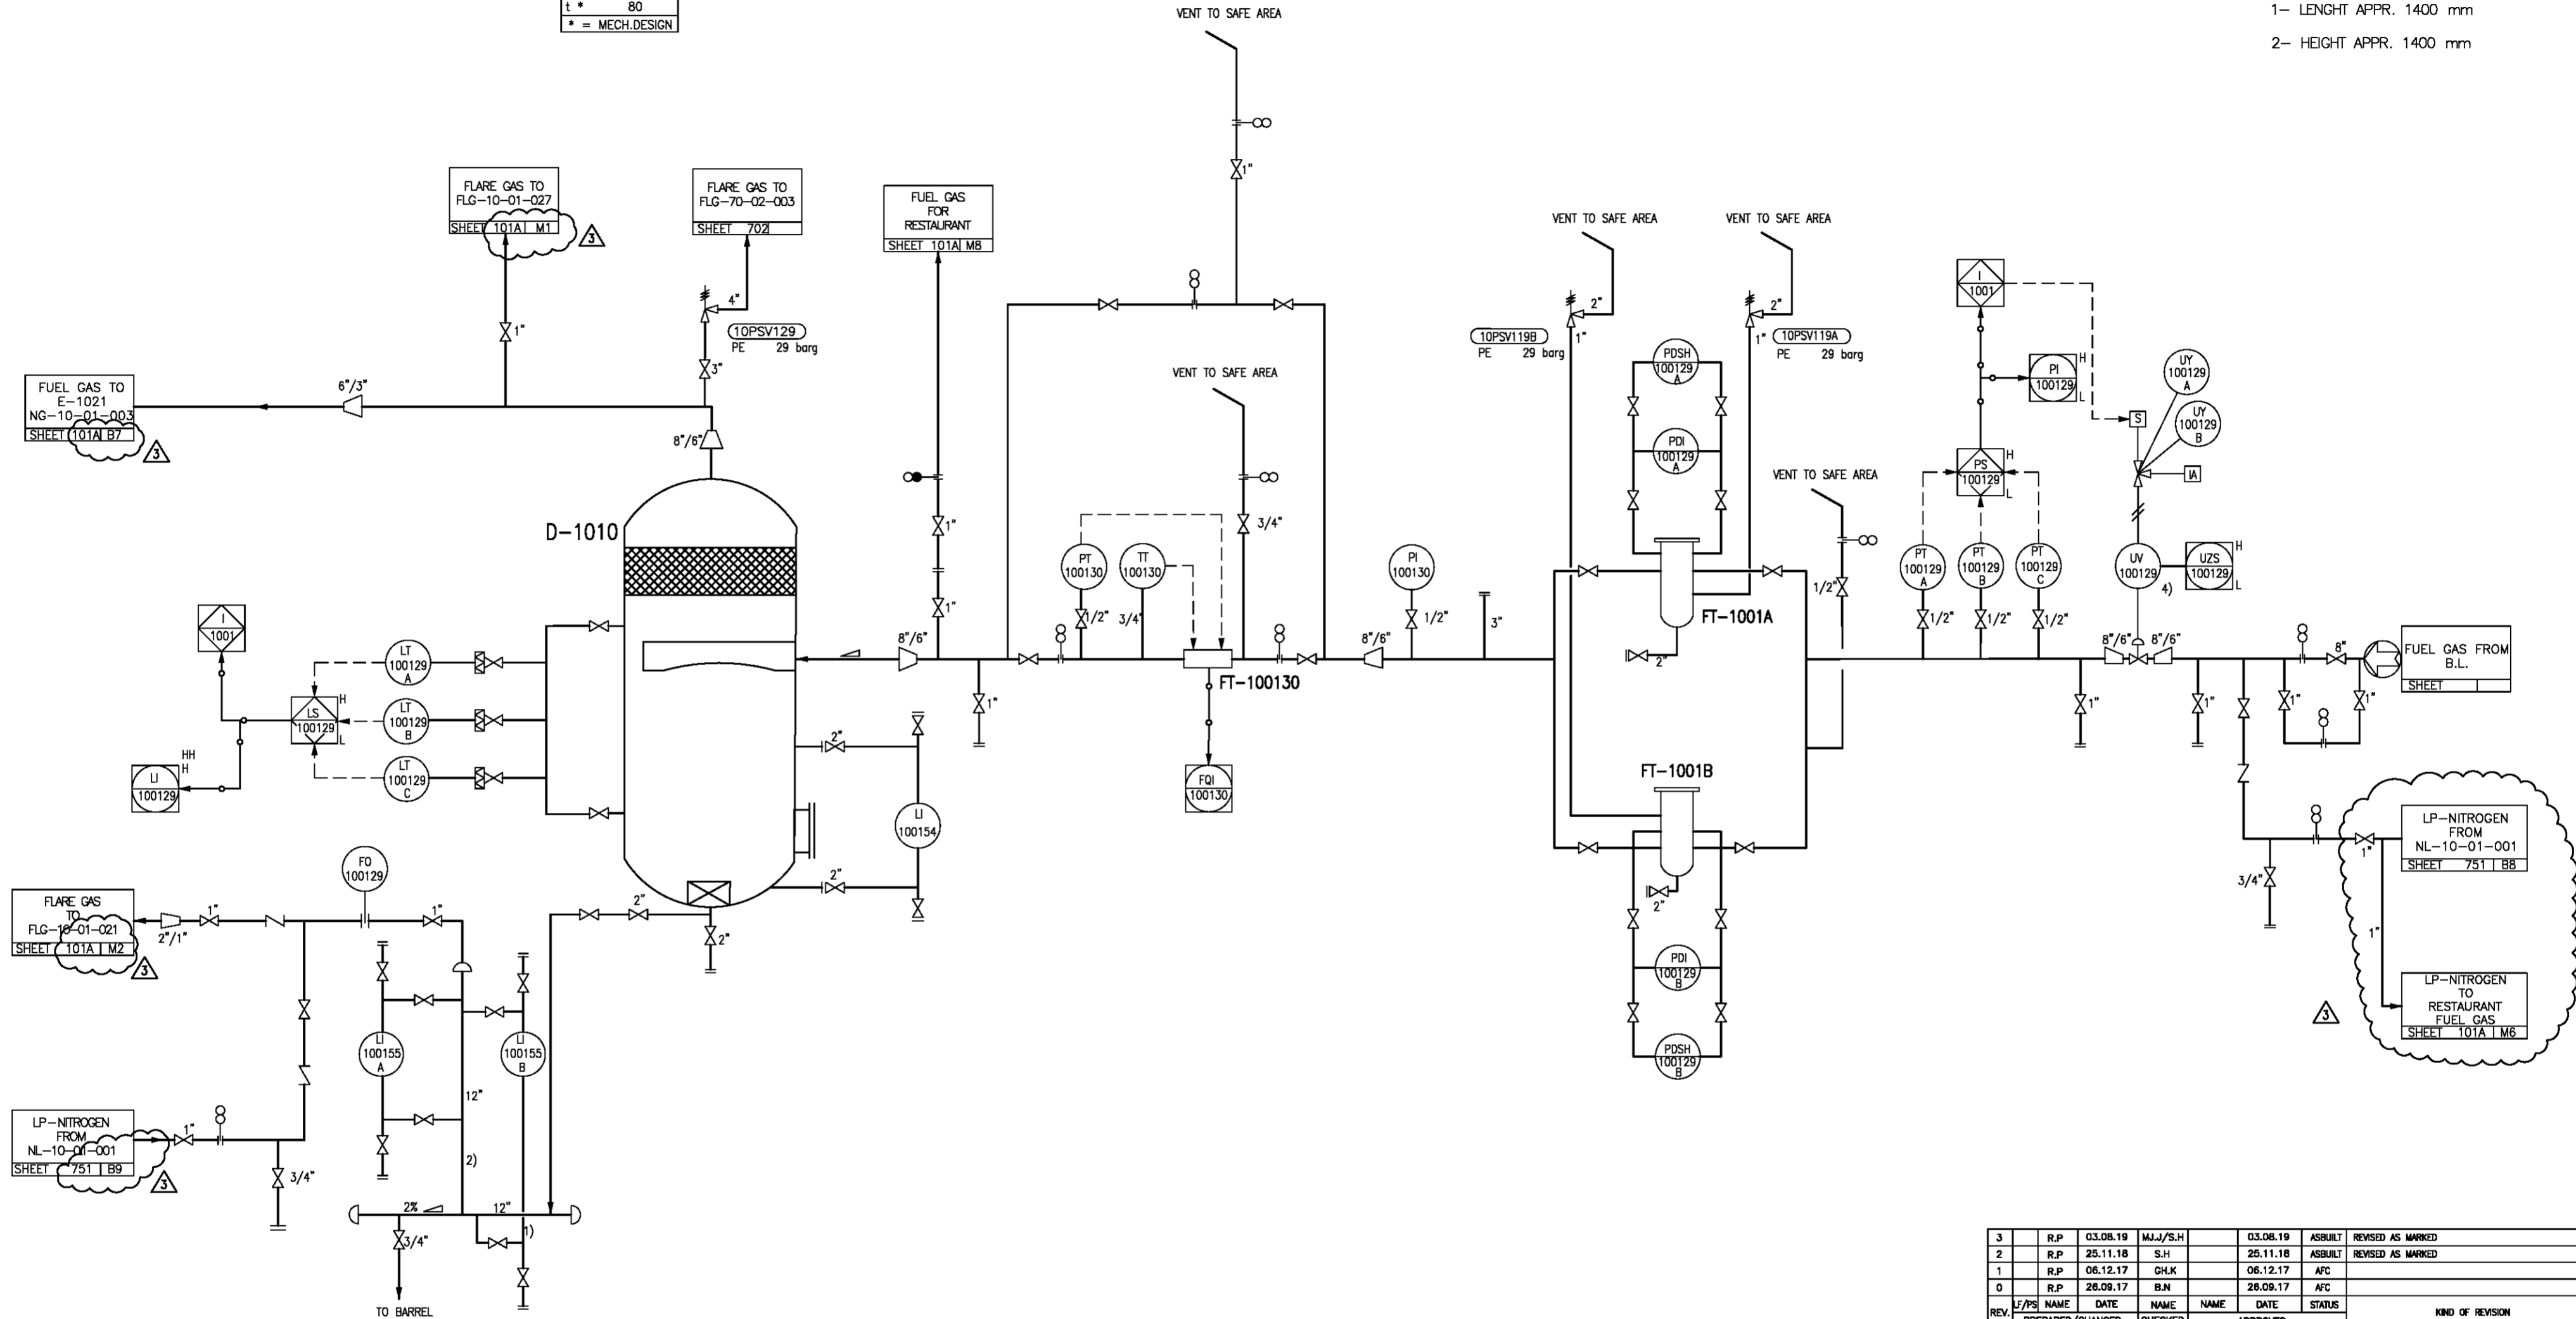

REV.	DATE	BY	CHKD	APPV	STATUS	KIND OF REVISION
3	03.08.19	MJJ/S.H			ASBUILT	REVISED AS MARKED
2	25.11.18	S.H			ASBUILT	REVISED AS MARKED
1	06.12.17	GHK			AFC	
0	28.09.17	B.N			AFC	

REV.	DATE	NAME	NAME	DATE	STATUS	KIND OF REVISION
		PREPARED/CHANGED	CHECKED	APPROVED		

DOPING OF THIS DOCUMENT, AND DIVING TO THE OTHERS AND THE USE COMMUNICATION OF THE CONTENTS THEREOF, ARE FORBIDDEN WITHOUT EXPRESS AUTHORITY BY LARS/PROG. OFFENDERS ARE LIABLE TO THE PAYMENT OF DAMAGES. ALL RIGHTS ARE RESERVED IN THE EVENT OF THE GRANT OF THE PATENT OR THE REGISTRATION OF THE UTILITY MODEL OR DESIGN.

ZAGROS PETROCHEMICAL COMPANY OWNER:

ZAGROS PETROCHEMICAL COMPANY
 شرکت پتروشیمی زاگرس

PROJECT:
4th METHANAOL PROJECT

REFORMING
 N.G. KNOCK- OUT DRUM
 UNIT 100
 P&ID DIAGRAM SHEET 101 B

NOMINATION: D-1008
 E-1021

JOB NAME: MEGA METHANOL IRAN Document No. REV. 3

DENOMINATION P&ID-Diagram DRAWING NUMBER SHEET 1 SH.