



D-3008 A/B

OD	1524mm
A	1.73m2
V	3.81m3
PX	7bar
TX	100°C
DP FOR TRANSMITTER	0-1bar
H ALARM	0.3bar
HH ALARM	0.5bar
X	ALLOWABLE

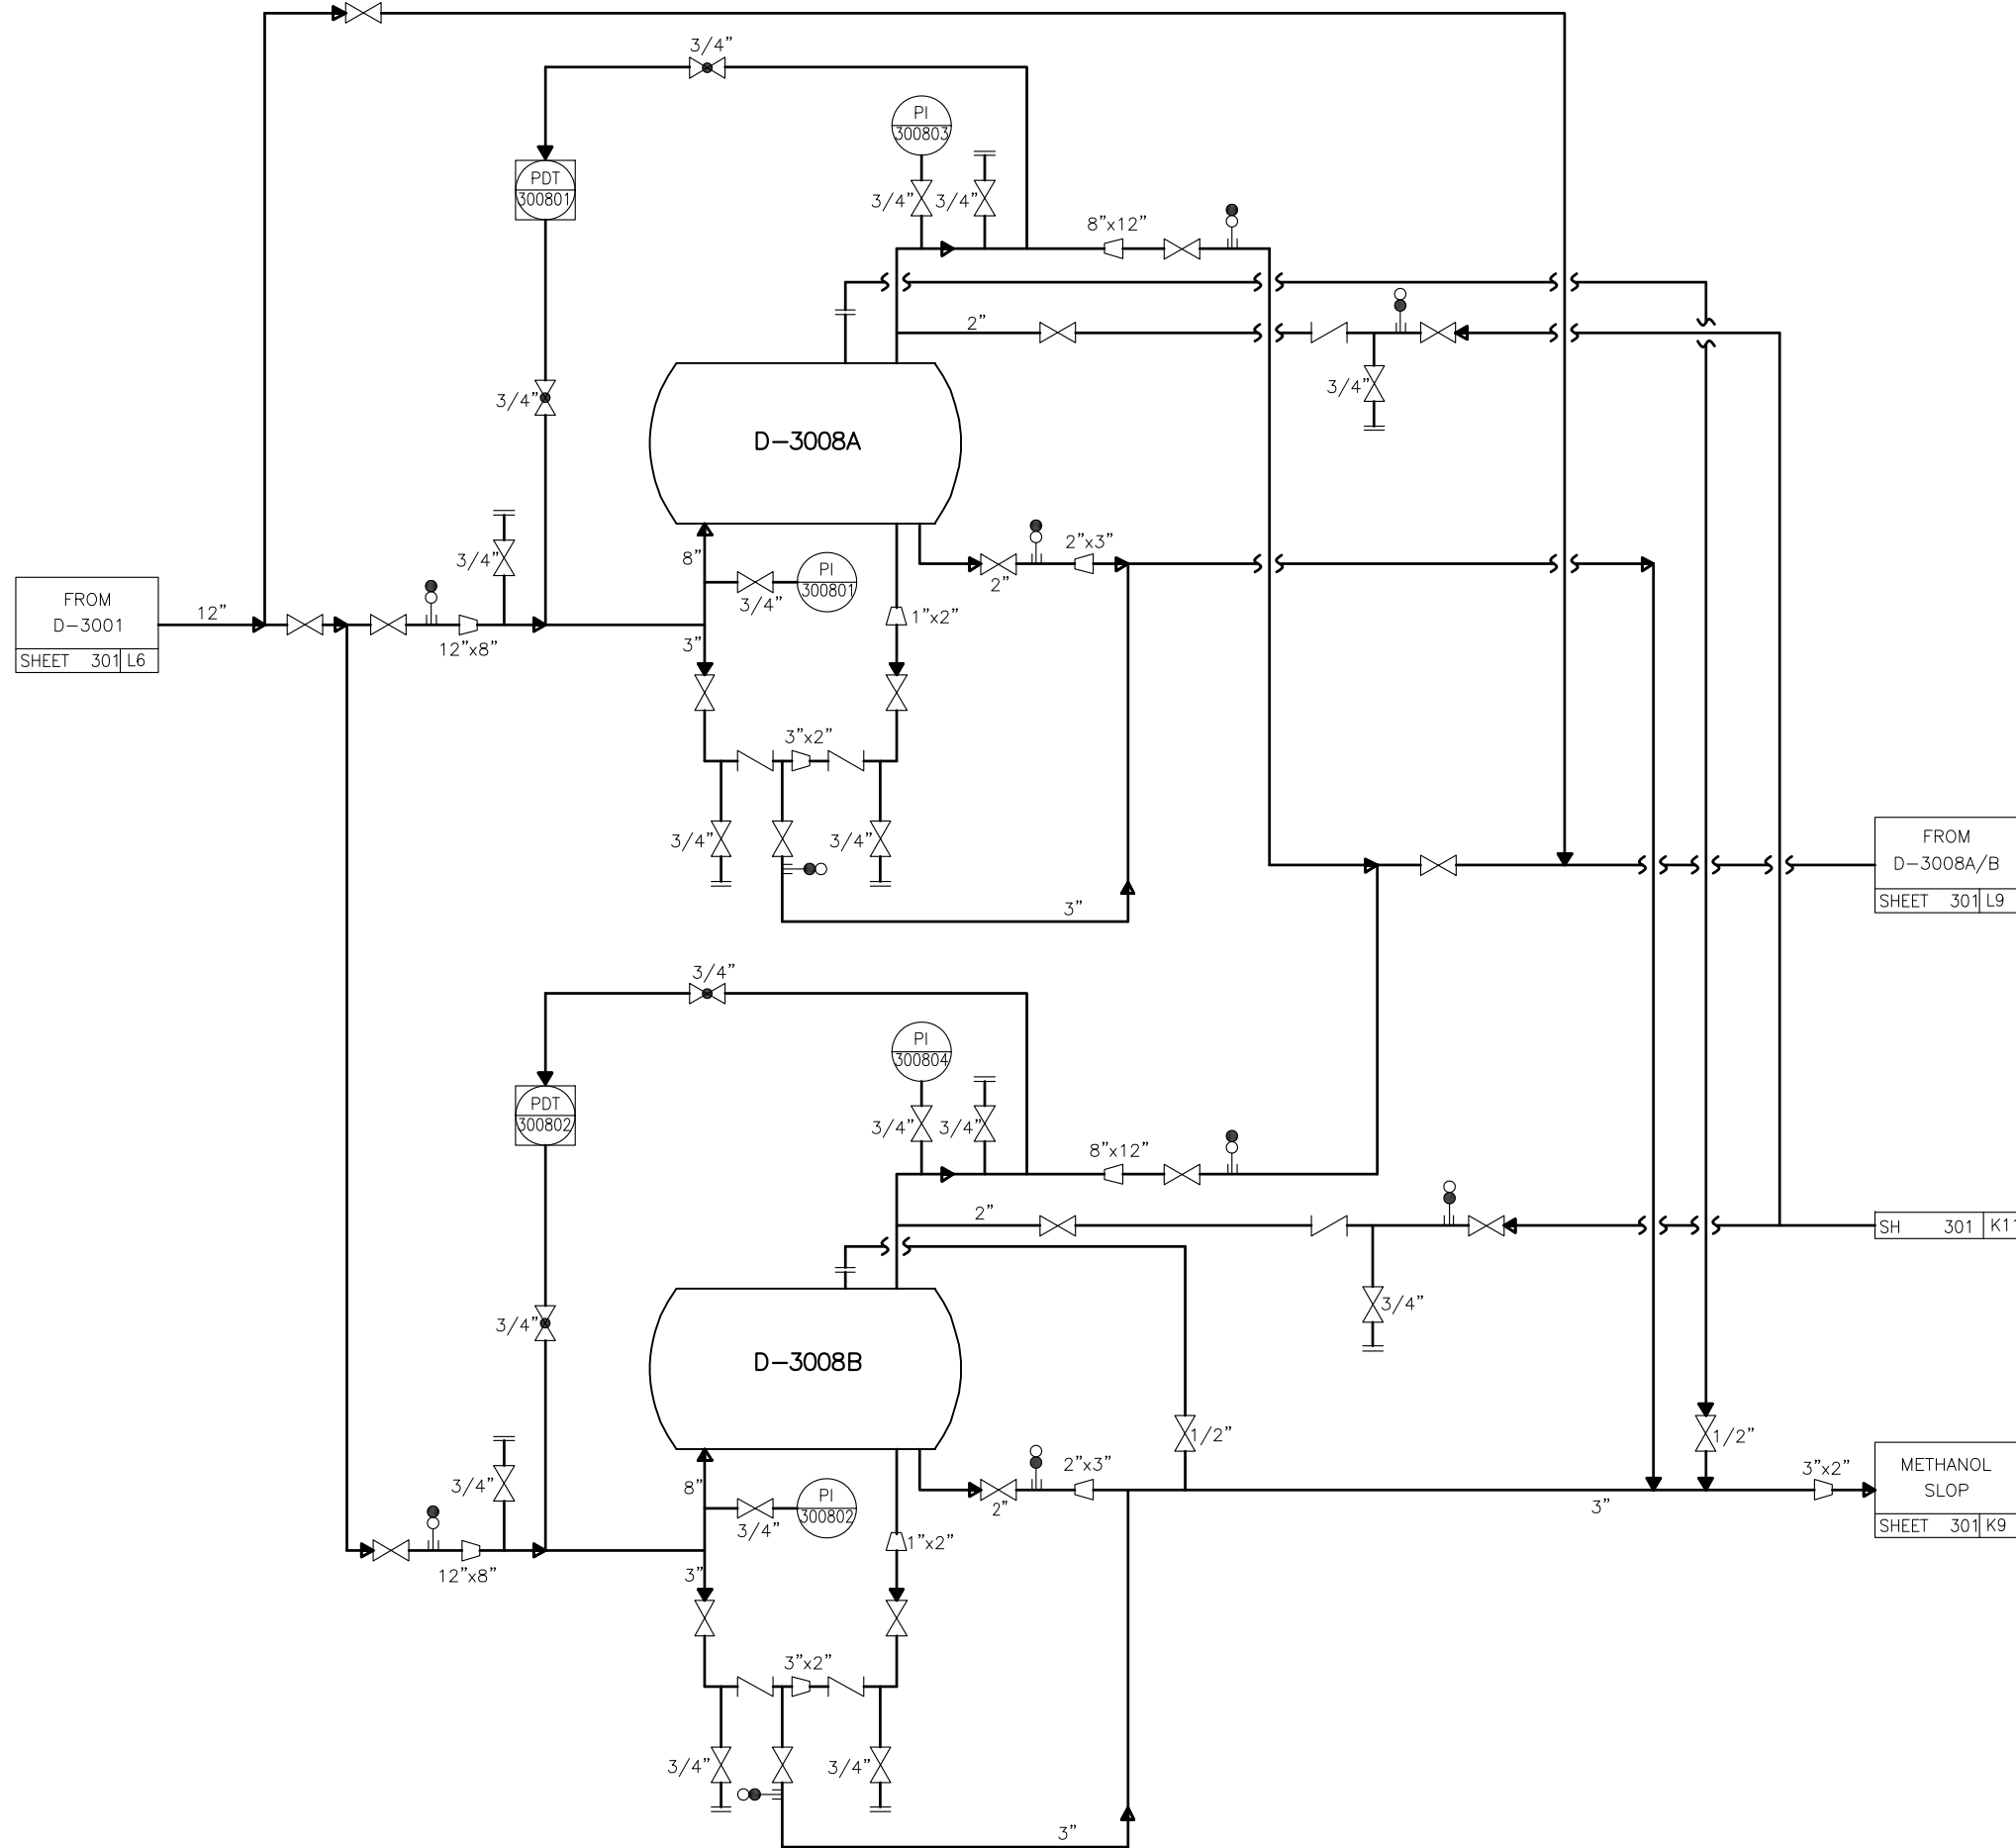

0	R.P	13.05.13	M.N		13.05.13	ASBUILT	REVISED AS MARKED
REV.	LF/PS	NAME	DATE	NAME	NAME	DATE	STATUS
		PREPARED/CHANGED	CHECKED	APPROVED			KIND OF REVISION
COPYING OF THIS DOCUMENT, AND GIVING IT TO THE OTHERS AND THE USE COMMUNICATION OF THE CONTENTS THEREOF, ARE FORBIDDEN WITHOUT EXPRESS AUTHORITY BY LURGI/PIDEC. OFFENDERS ARE LIABLE TO THE PAYMENT OF DAMAGES. ALL RIGHTS ARE RESERVED IN THE EVENT OF THE GRANT OF THE PATENT OR THE REGISTRATION OF THE UTILITY MODEL OR DESIGN.							
ZAGROS PETROCHEMICAL COMPANY				OWNER:  ZAGROS PETROCHEMICAL COMPANY شرکت پتروشیمی زاگرس			
DISPOSITION: <input type="checkbox"/> NO COMMENT <input type="checkbox"/> COMMENTS AS MARKED: FABRICATION CAN PROCEED ACCORDINGLY; REVISED DOCT TO BE ISSUED EITHER FOR REVIEW OR AS FINAL CERTIFIED. HOWEVER ZAGROS WILL CHECK THIS REVISED DOCUMENT FOR PROPER INCORPORATION. <input type="checkbox"/> REJECTED DOCUMENT TO BE REISSUED. <input type="checkbox"/> USE FOR INFORMATION ONLY.				PROJECT: 4th METHANOL PROJECT			
SIGNATURE				DATE			
ZAGROS REVIEW & COMMENTS DOES NOT ABSOLVE THE VENDOR OF THE RESPONSIBILITY FOR THE CORRECT DESIGN, MANUFACTURING AND OPERATION OF EQUIPMENT.				NOMINATION: D-3008 A/B			
JOB NAME: MEGA METHANOL IRAN				Document No. 37156			REV. 0
DENOMINATION P&ID-Diagram						DRAWING NUMBER	SHEET 1 SH.