


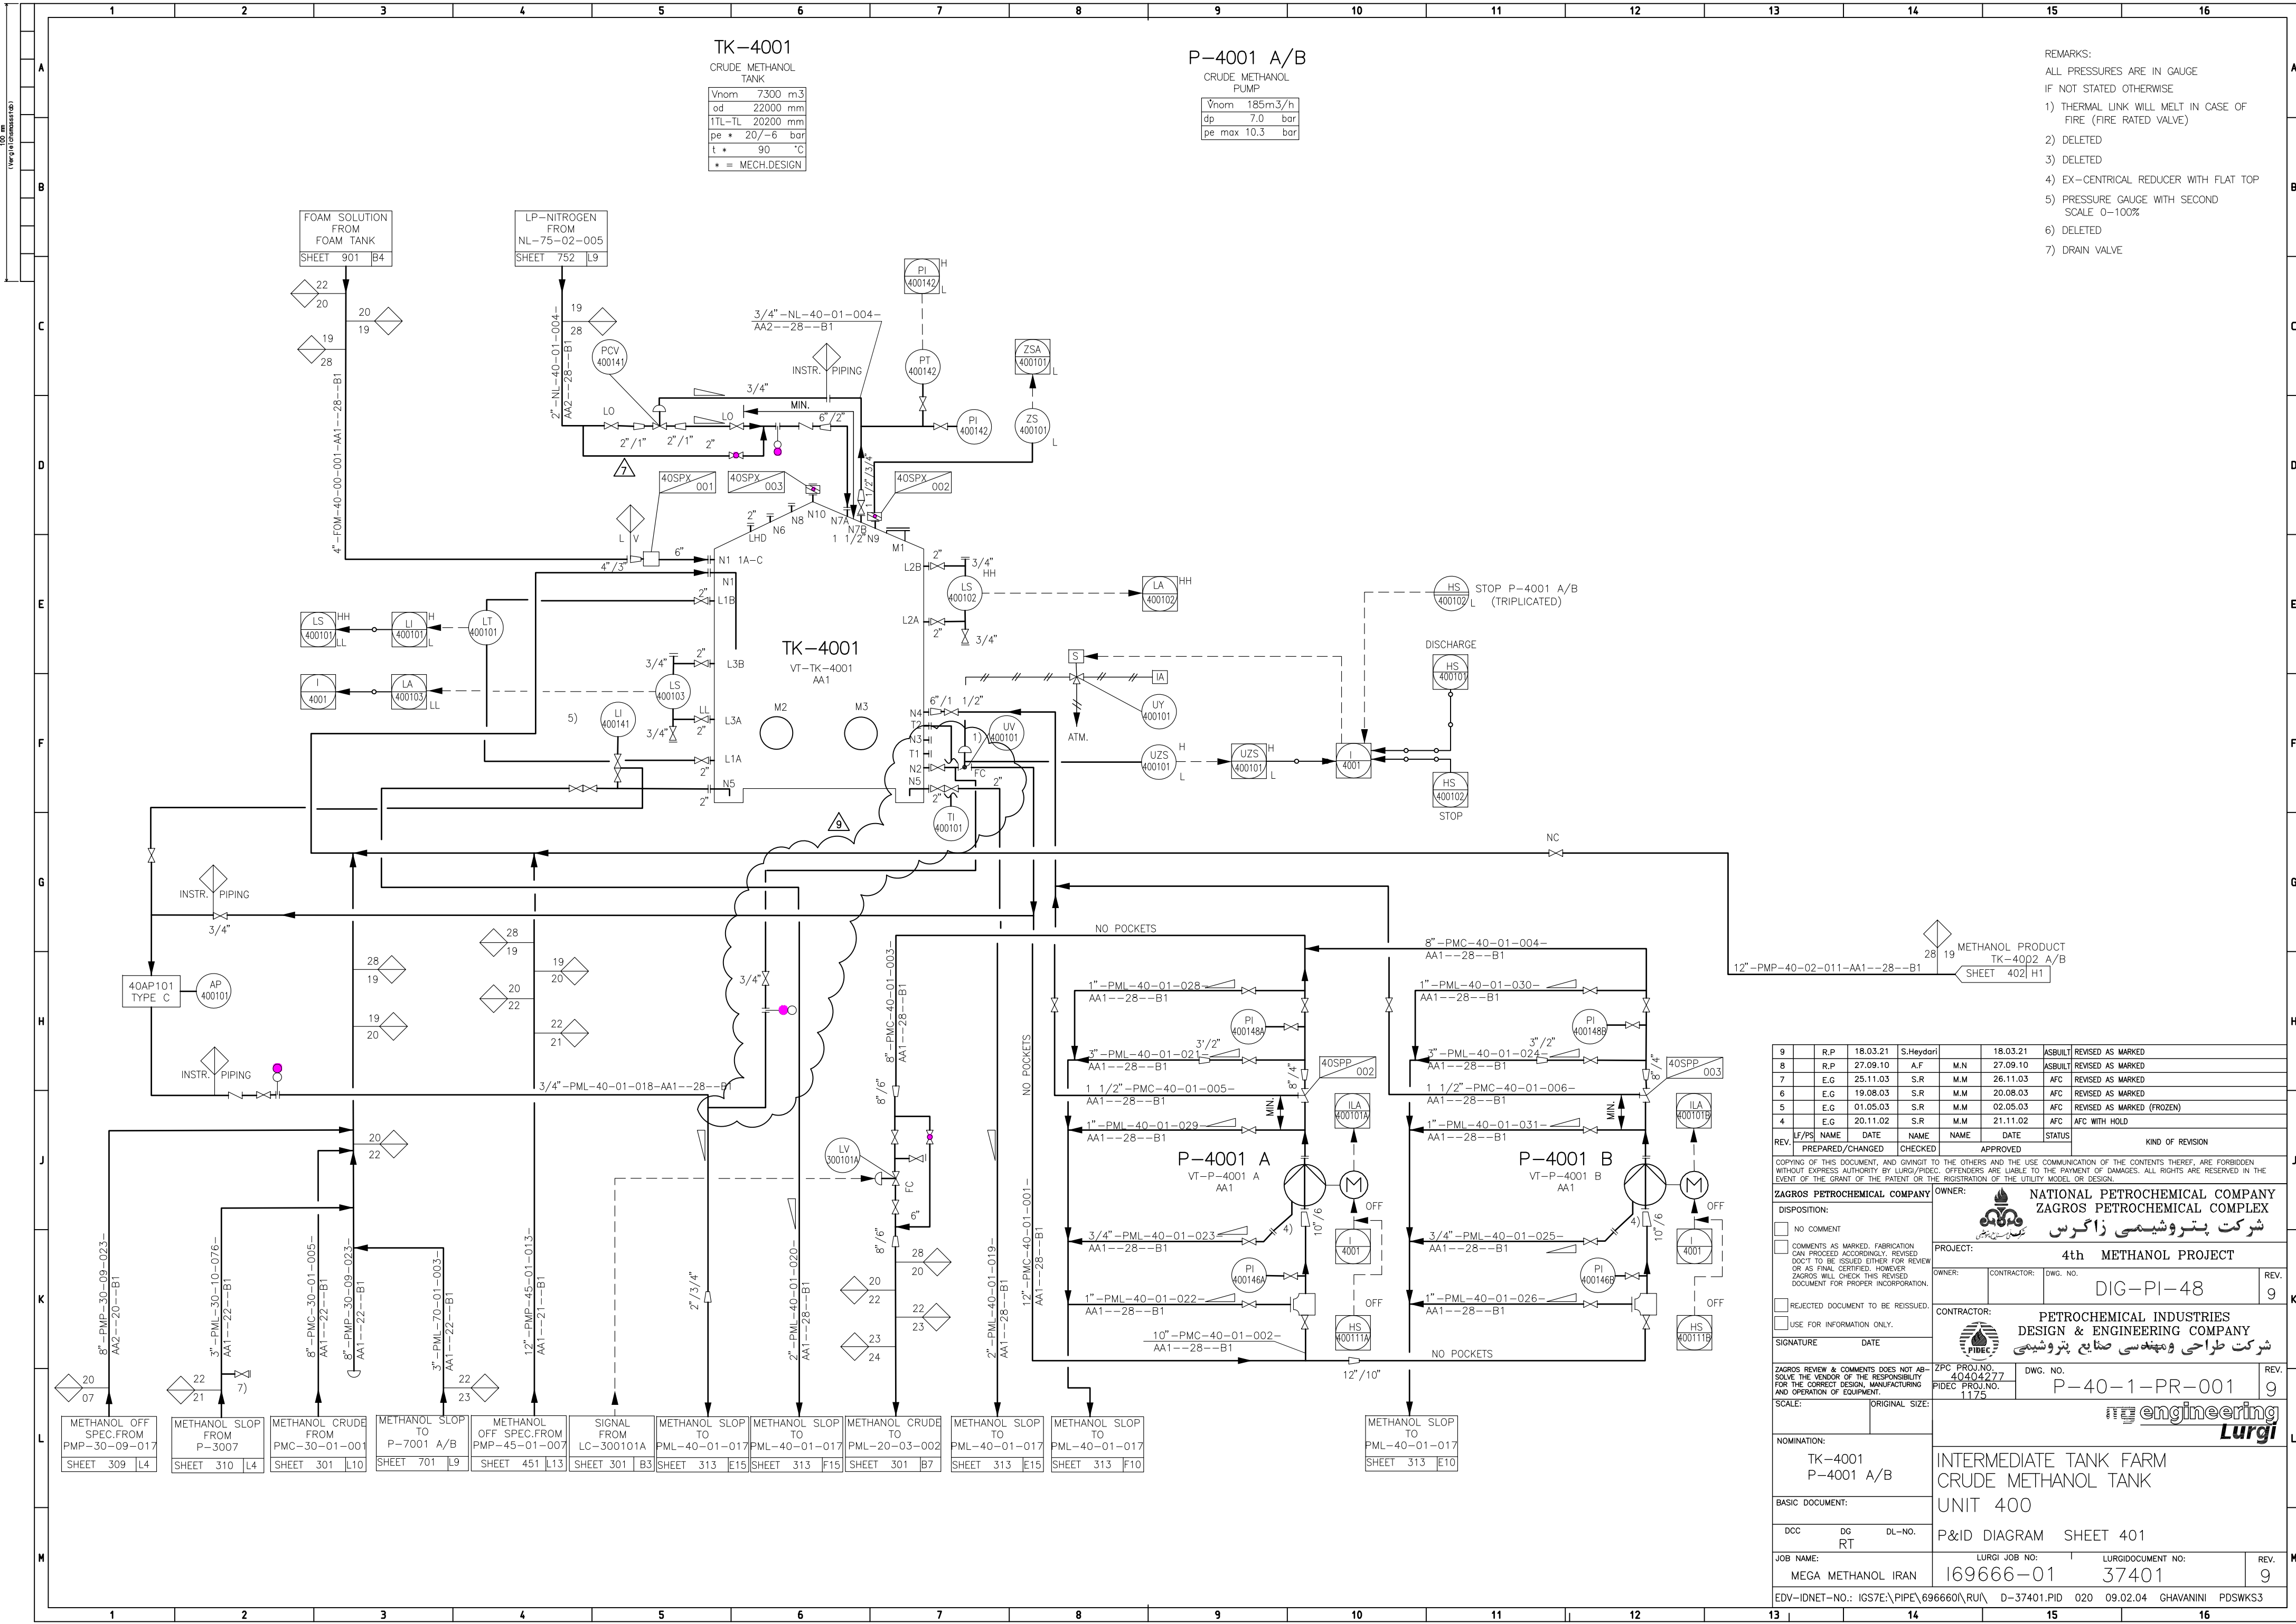

- REMARKS:
- ALL PRESSURES ARE IN GAUGE
 - IF NOT STATED OTHERWISE
 - 1) THERMAL LINK WILL MELT IN CASE OF FIRE (FIRE RATED VALVE)
 - 2) DELETED
 - 3) DELETED
 - 4) EX-CENTRICAL REDUCER WITH FLAT TOP
 - 5) PRESSURE GAUGE WITH SECOND SCALE 0-100%
 - 6) DELETED
 - 7) DRAIN VALVE

9	R.P.	18.03.21	S.Heydari	18.03.21	ASBUILT	REVISED AS MARKED		
8	R.P.	27.09.10	A.F.	M.N.	27.09.10	ASBUILT	REVISED AS MARKED	
7	E.G.	25.11.03	S.R.	M.M.	26.11.03	AFC	REVISED AS MARKED	
6	E.G.	19.08.03	S.R.	M.M.	20.08.03	AFC	REVISED AS MARKED	
5	E.G.	01.05.03	S.R.	M.M.	02.05.03	AFC	REVISED AS MARKED (FROZEN)	
4	E.G.	20.11.02	S.R.	M.M.	21.11.02	AFC	AFC WITH HOLD	
REV.	LF/PS	NAME	DATE	NAME	DATE	STATUS	KIND OF REVISION	
		PREPARED/CHANGED		CHECKED		APPROVED		
COPYING OF THIS DOCUMENT, AND GIVING IT TO THE OTHERS AND THE USE COMMUNICATION OF THE CONTENTS THEREOF, ARE FORBIDDEN WITHOUT EXPRESS AUTHORITY BY LURGI/PIDEC. OFFENDERS ARE LIABLE TO THE PAYMENT OF DAMAGES. ALL RIGHTS ARE RESERVED IN THE EVENT OF THE GRANT OF THE PATENT OR THE REGISTRATION OF THE UTILITY MODEL OR DESIGN.								
ZAGROS PETROCHEMICAL COMPANY				OWNER:  NATIONAL PETROCHEMICAL COMPANY ZAGROS PETROCHEMICAL COMPLEX شرکت پتروشیمی زاگرس				
DISPOSITION:				PROJECT: 4th METHANOL PROJECT				
☐ NO COMMENT				OWNER: CONTRACTOR: DWG. NO. DIG-PI-48				REV. 9
☐ COMMENTS AS MARKED. FABRICATION CAN PROCEED ACCORDINGLY. REVISED DOC'T TO BE ISSUED EITHER FOR REVIEW OR AS FINAL CERTIFIED. HOWEVER ZAGROS WILL CHECK THIS REVISED DOCUMENT FOR PROPER INCORPORATION.				CONTRACTOR: PETROCHEMICAL INDUSTRIES DESIGN & ENGINEERING COMPANY شرکت طراحی و مهندسی صنایع پتروشیمی				
☐ REJECTED DOCUMENT TO BE REISSUED.				ZPC PROJ.NO. 40404277 PIDEC PROJ.NO. 1175				REV. 9
☐ USE FOR INFORMATION ONLY.				DWG. NO. P-40-1-PR-001				
SIGNATURE				DATE				
ZAGROS REVIEW & COMMENTS DOES NOT ABSOLVE THE VENDOR OF THE RESPONSIBILITY FOR THE CORRECT DESIGN, MANUFACTURING AND OPERATION OF EQUIPMENT.				SCALE: ORIGINAL SIZE: 				
NOMINATION: TK-4001 P-4001 A/B				INTERMEDIATE TANK FARM CRUDE METHANOL TANK UNIT 400				
BASIC DOCUMENT: DCC DG DL-NO. RT				P&ID DIAGRAM SHEET 401				
JOB NAME: MEGA METHANOL IRAN				LURGI JOB NO: 169666-01 37401				REV. 9
EDV-IDNET-NO.: IGS7E:\PIPE\696660\RU\ D-37401.PID 020 09.02.04 GHAVANINI PDSWKS3								