


PURE METHANOL
STORAGE TANK

Vnom	64700	m3
od	63000	mm
ITL-TL	24100	mm
pe x	15/-6	mbars
t x	90	°C
x = MECH.DESIGN		

REMARKS:

ALL PRESSURES ARE IN GAUGE
IF NOT STATED OTHERWISE

- 1) FIXED SET POINT FORCED IN CONTINUOUS AUTOMATIC MODE.
- 2) THERMAL LINK , WILL MELT IN CASE OF FIRE (FIRE RATED VALVE)
- 3) DELETED.
- 4) CLOSE TO N.4
- 5) PRESSURE GAUGE WITH SECOND SCALE 0-100%
- 6) DELETED.
- 7) FOUR MAN-HOLES TO BE INSTALLED ON THE TANK SHELL.
- 8) ONE 10" AND ONE 12" RIM VENT TO BE PROVIDED ON THE FLOATING ROOF.

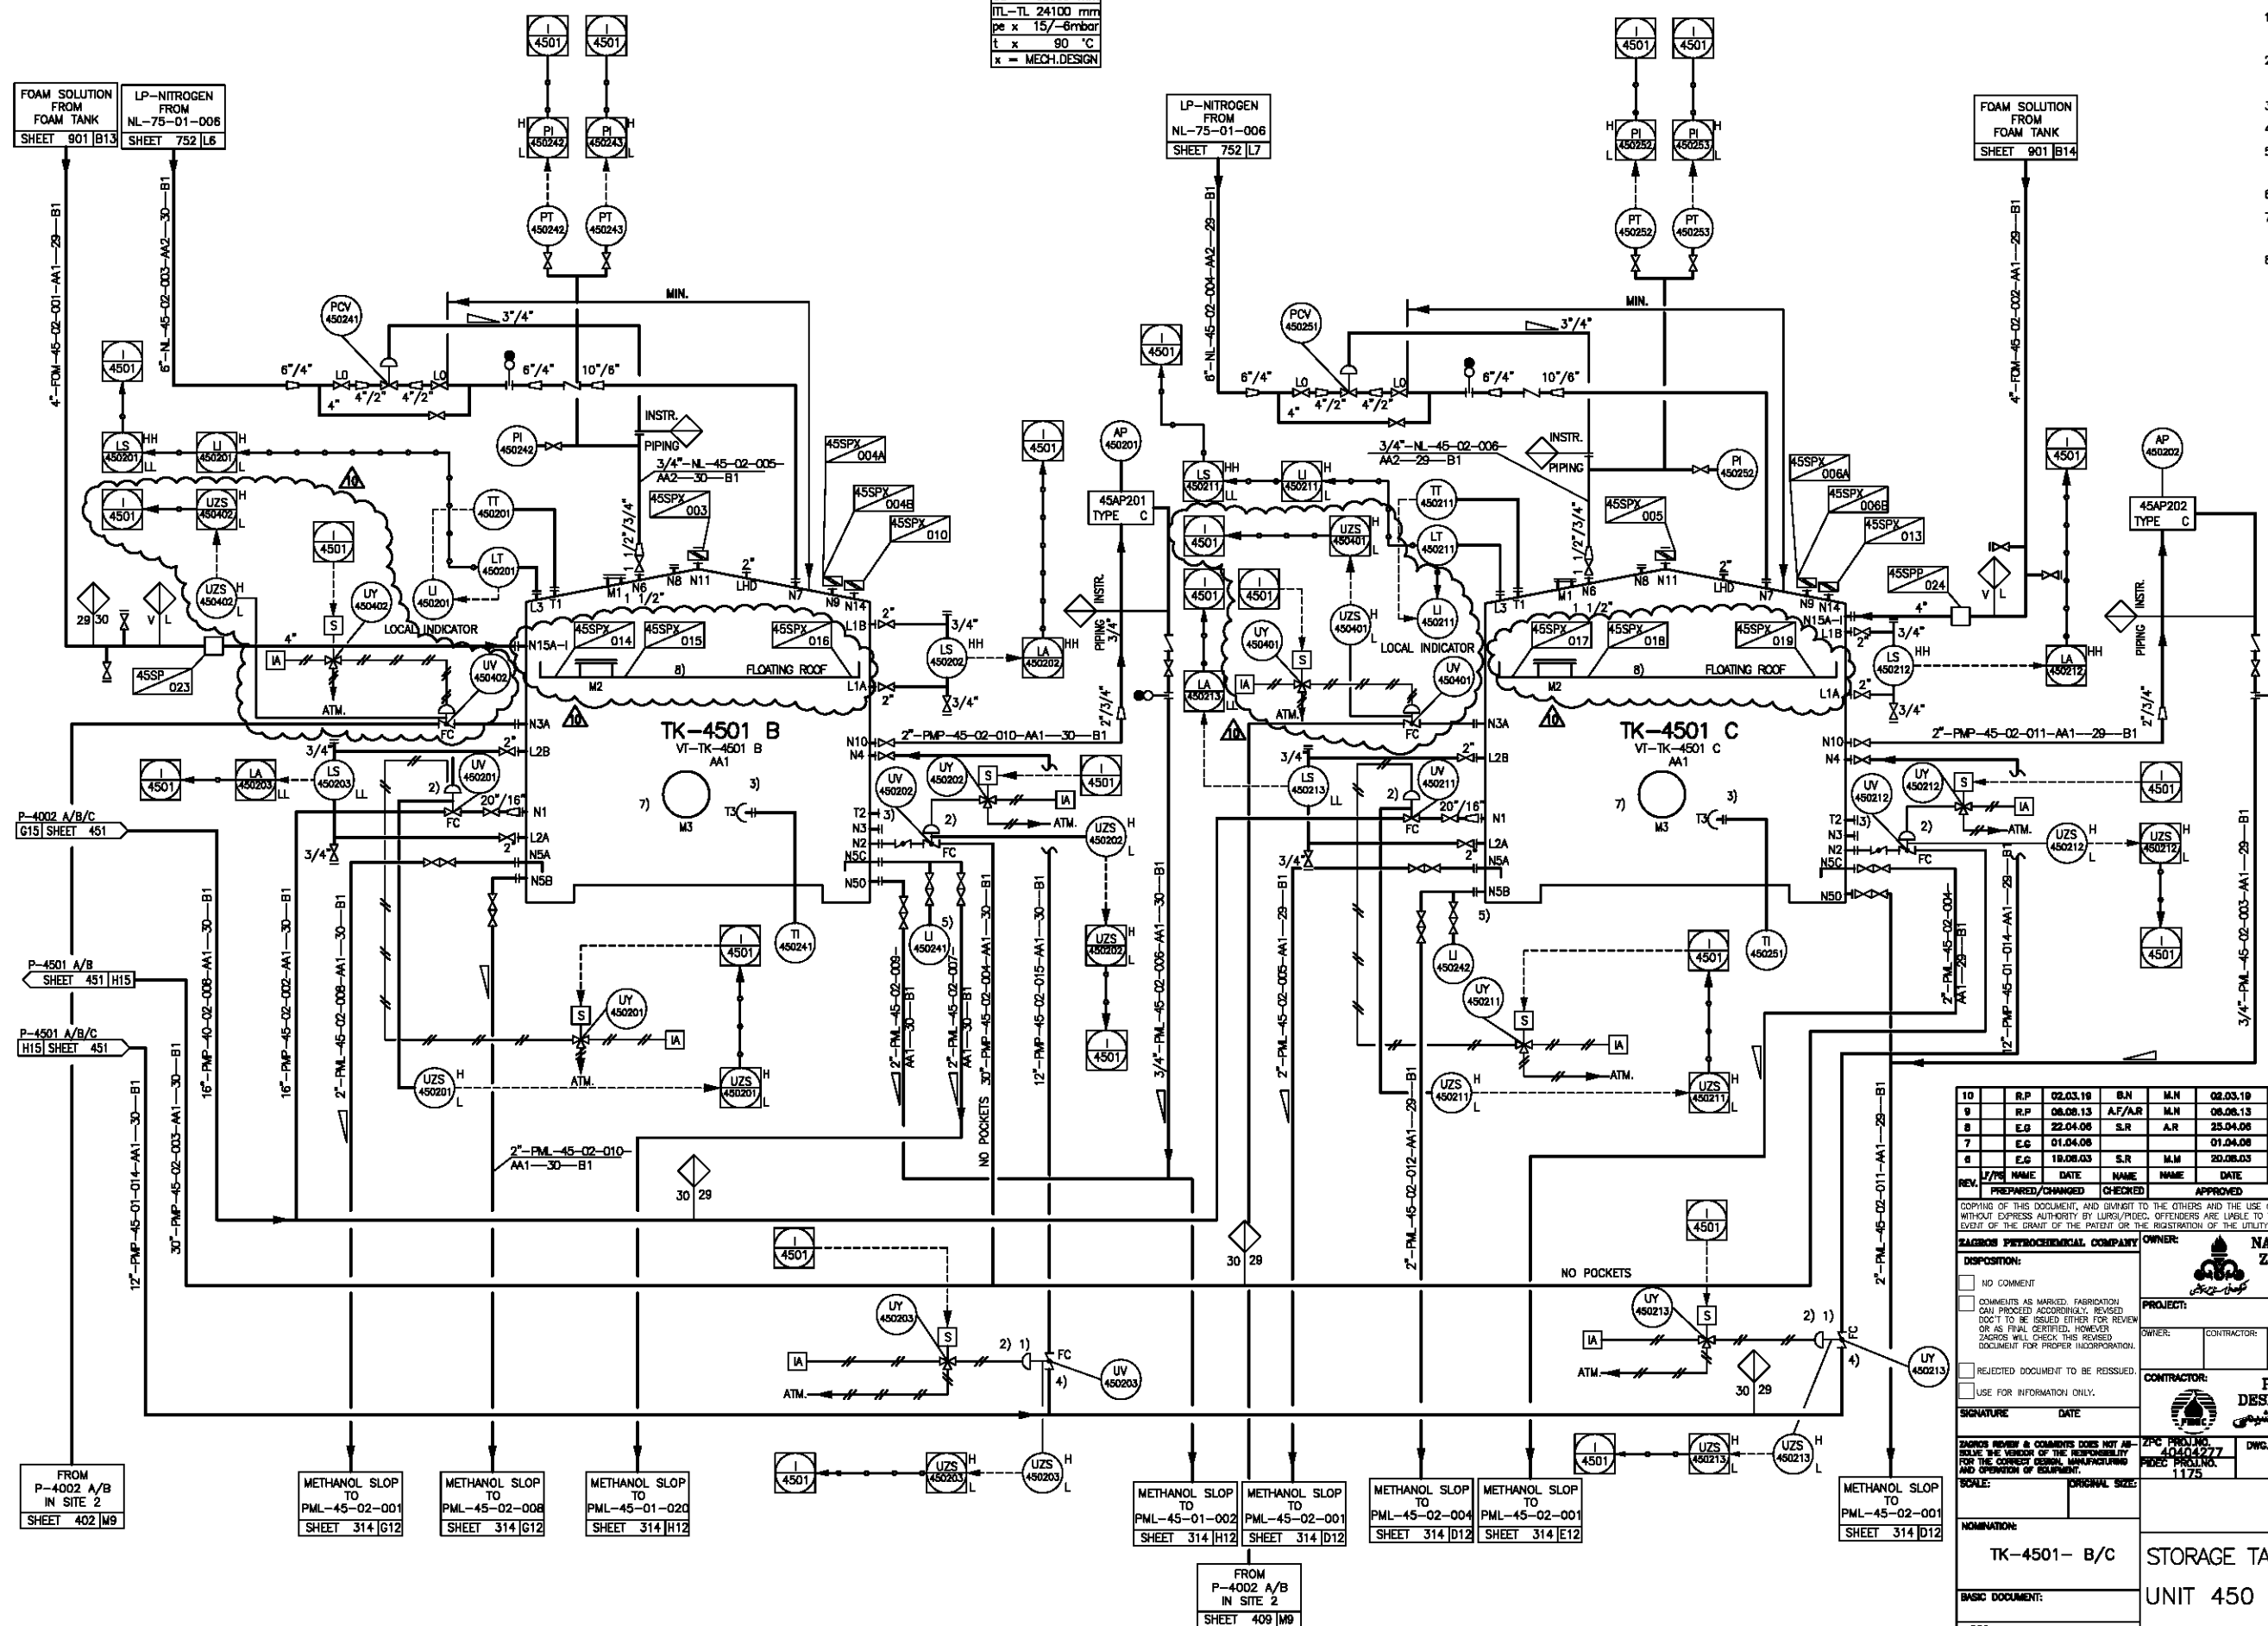

10	R.P	02.03.19	B.N	M.N	02.03.19	Author	REMOVED AS MARKED
9	R.P	06.08.13	A.F/A.R	M.N	06.08.13	Author	REMOVED AS MARKED
8	E.G	22.04.06	S.R	A.R	25.04.06	AFC	REMOVED AS MARKED
7	E.G	01.04.06			01.04.06	AFD	NO ISSUE
6	E.G	18.08.03	S.R	M.M	20.08.03	AFC	REMOVED AS MARKED
REV.	J/P	NAME	DATE	NAME	DATE	STATUS	KIND OF REVISION
		PREPARED	DRAWN	CHECKED	APPROVED		

COPYING OF THIS DOCUMENT, AND DIVULG TO THE OTHERS AND THE USE COMMUNICATION OF THE CONTENTS THEREOF, ARE FORBIDDEN WITHOUT EXPRESS AUTHORITY BY LURPS/POEC. OFFENDERS ARE LIABLE TO THE PAYMENT OF DAMAGES. ALL RIGHTS ARE RESERVED IN THE EVENT OF THE GRANT OF THE PATENT OR THE REGISTRATION OF THE UTILITY MODEL OR DESIGN.

ZAGROS PETROCHEMICAL COMPANY		OWNER:		NATIONAL PETROCHEMICAL COMPANY ZAGROS PETROCHEMICAL COMPLEX	
DISPOSITION:				شركة پتروشیمی زاگرس	
☐ NO COMMENT ☐ COMMENTS AS MARKED. FABRICATION CAN PROCEED ACCORDINGLY. REVISED DOTT TO BE ISSUED EITHER FOR REVIEW OR AS FINAL CERTIFIED. HOWEVER, ZAGROS WILL CHECK THIS REVISED DOCUMENT FOR PROPER INCORPORATION.		PROJECT:		4th METHANOL PROJECT	
☐ REJECTED DOCUMENT TO BE REISSUED. ☐ USE FOR INFORMATION ONLY.		OWNER:		CONTRACTOR: DWG. NO.	
SIGNATURE		DATE		DIG-PI-051	
ZAGROS REVIEW & COMMENTS DOES NOT ABOLISH THE VERSION OF THE RESPONSIBILITY FOR THE CORRECT DESIGN, MANUFACTURING AND OPERATION OF EQUIPMENT.		CONTRACTOR:		PETROCHEMICAL INDUSTRIES DESIGN & ENGINEERING COMPANY	
		ZPC PROJ.NO. 40404277		DWG. NO.	
SCALE:		P&ID PROJ.NO. 1175		P-45-1-PR-002	
ORIGINAL SIZE:		DWG. NO.		P-45-1-PR-002	
NOMINATION:		STORAGE TANKS AND LOADING		UNIT 450	
BASIC DOCUMENT:		P&I DIAGRAM SHEET 452			
DCC		DL-NO.			
DO		RT			
JOB NAME:		LURGI JOB NO:		LURGI DOCUMENT NO:	
MEGA METHANOL IRAN		169666-01		37452	
p/pe/6866801/nul/dwg.2-685		d-37452.pid		18.04.06 GHAVANINI POSHKS3	