

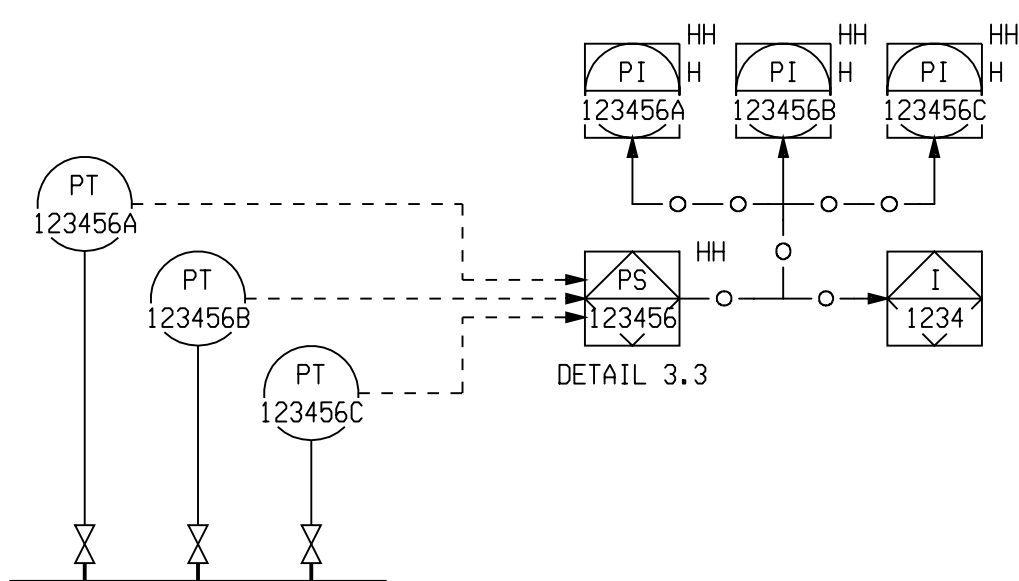
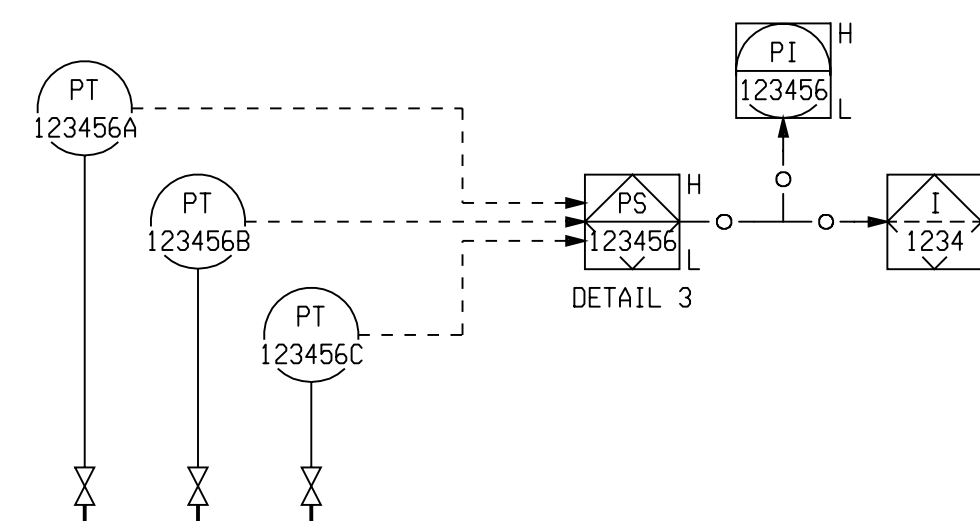
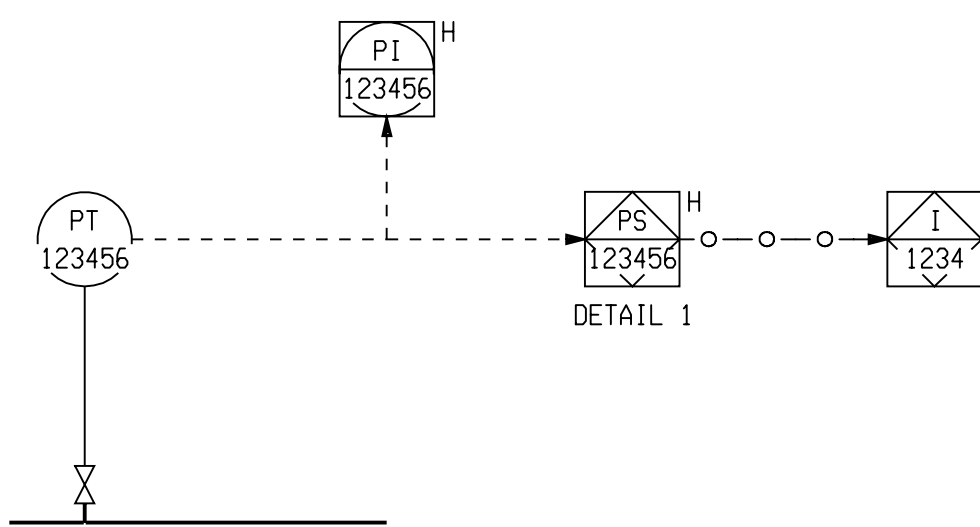
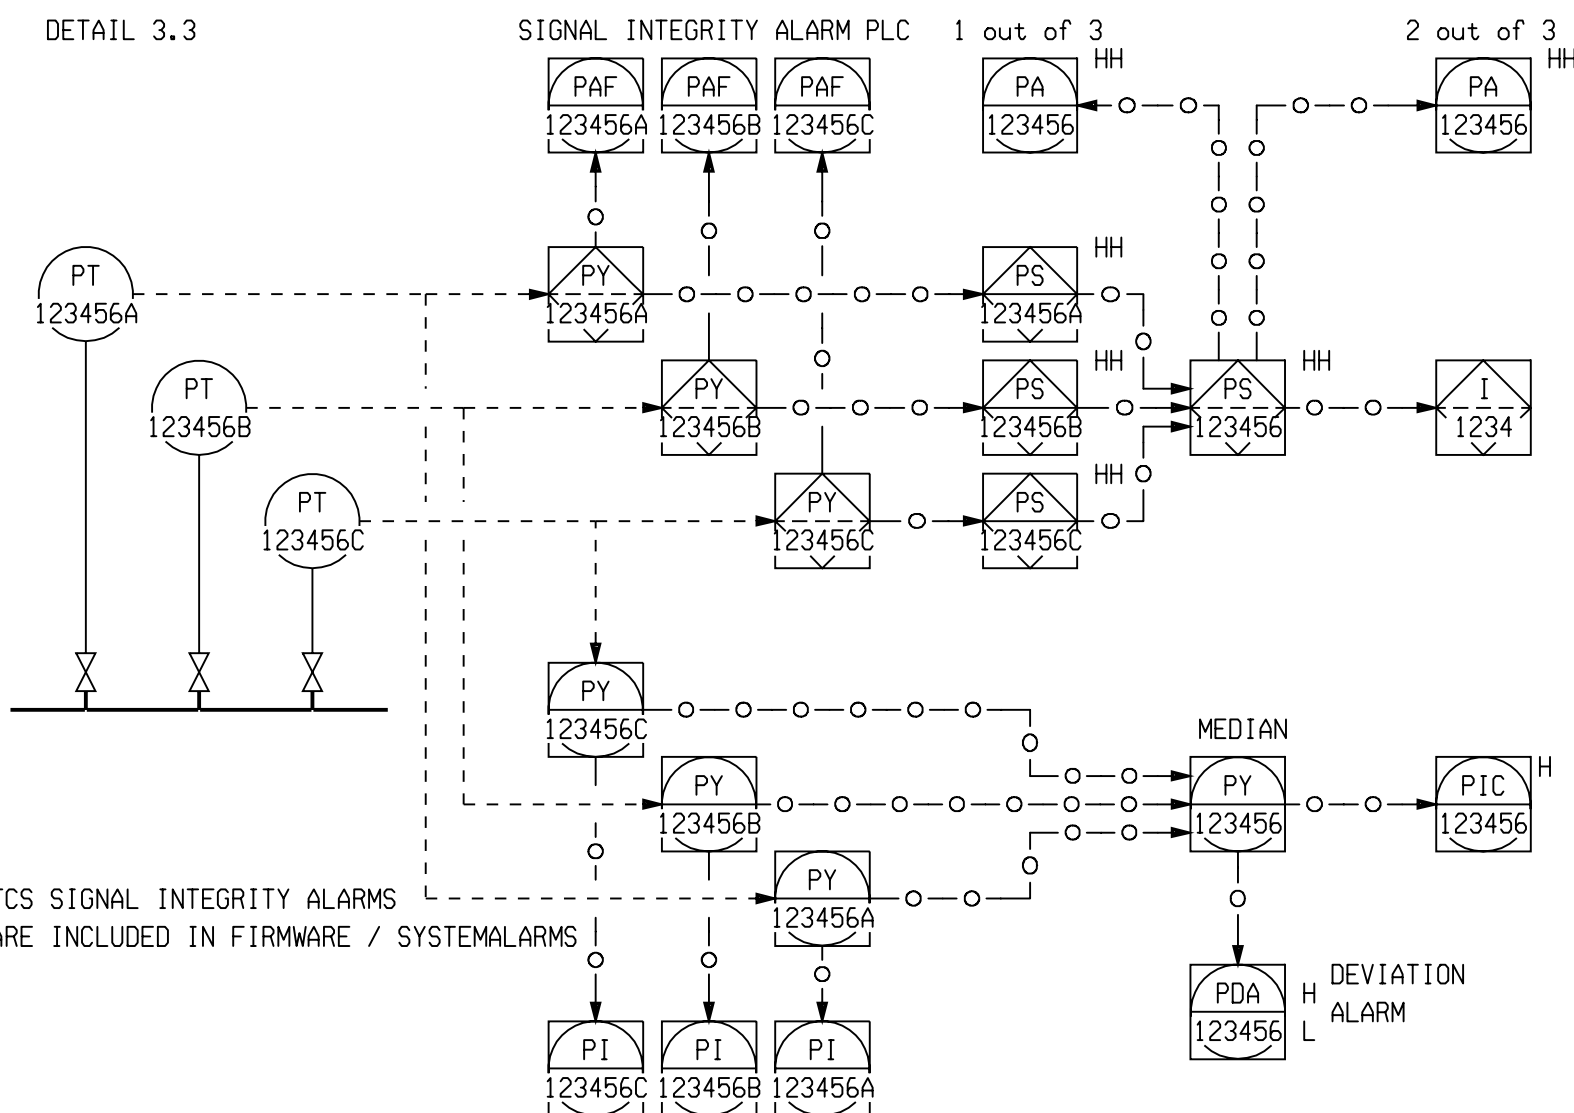




P&ID SHORT FORM

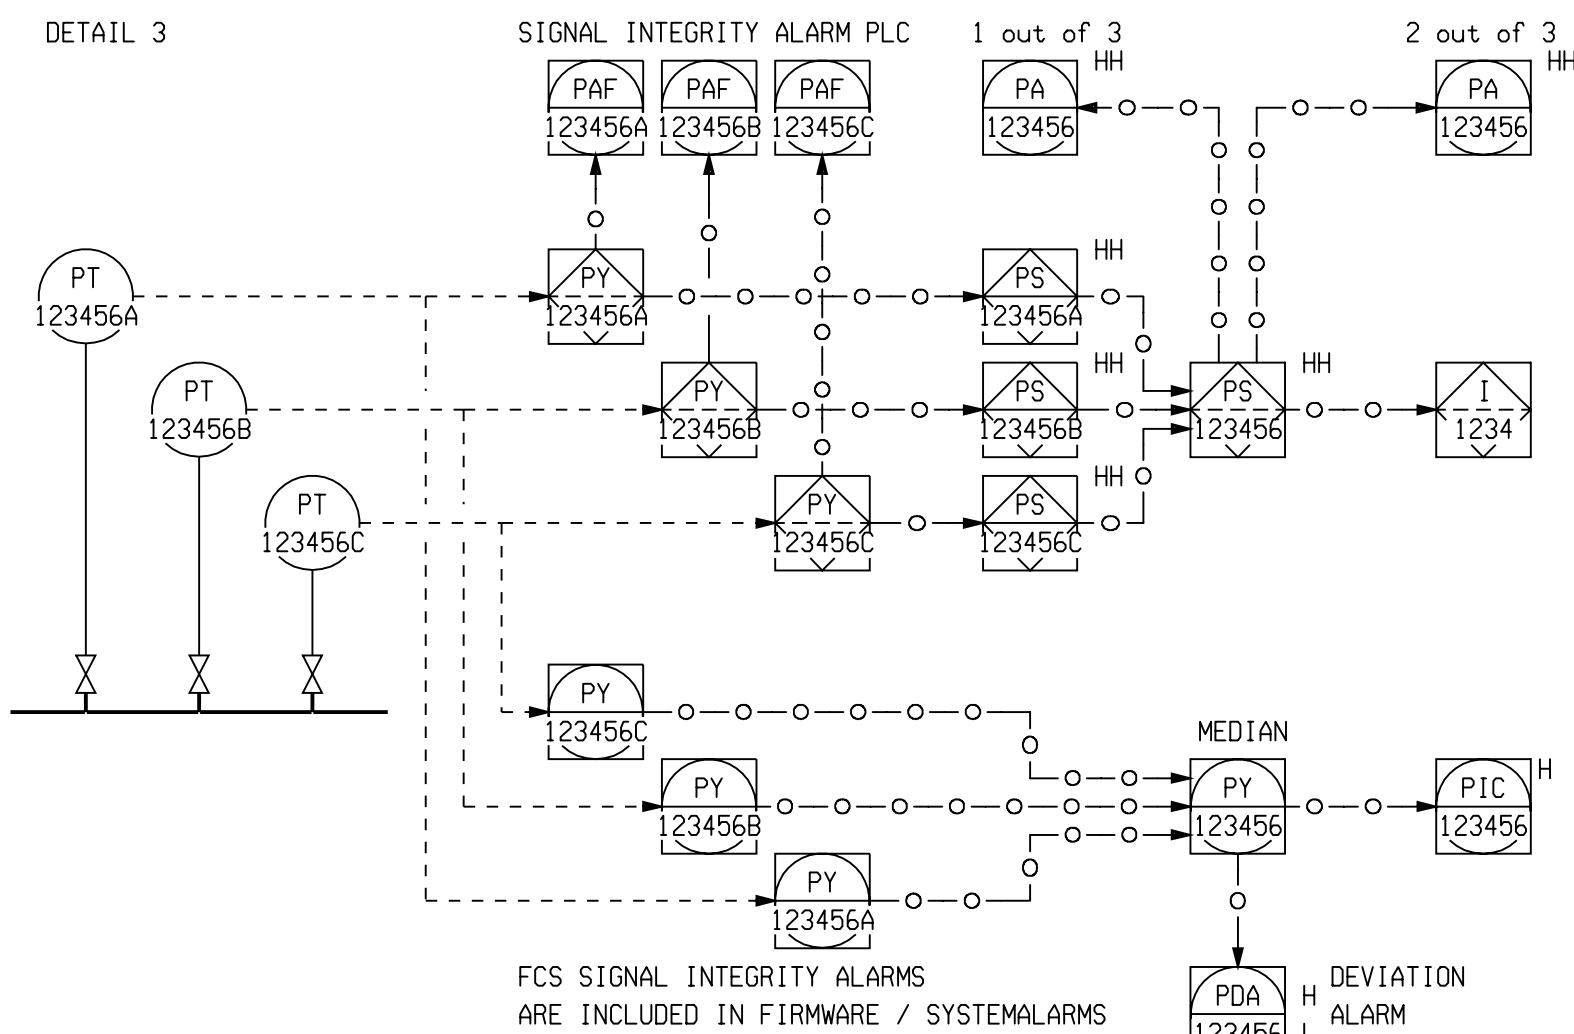

REAL HARDWARE CONFIGURATION

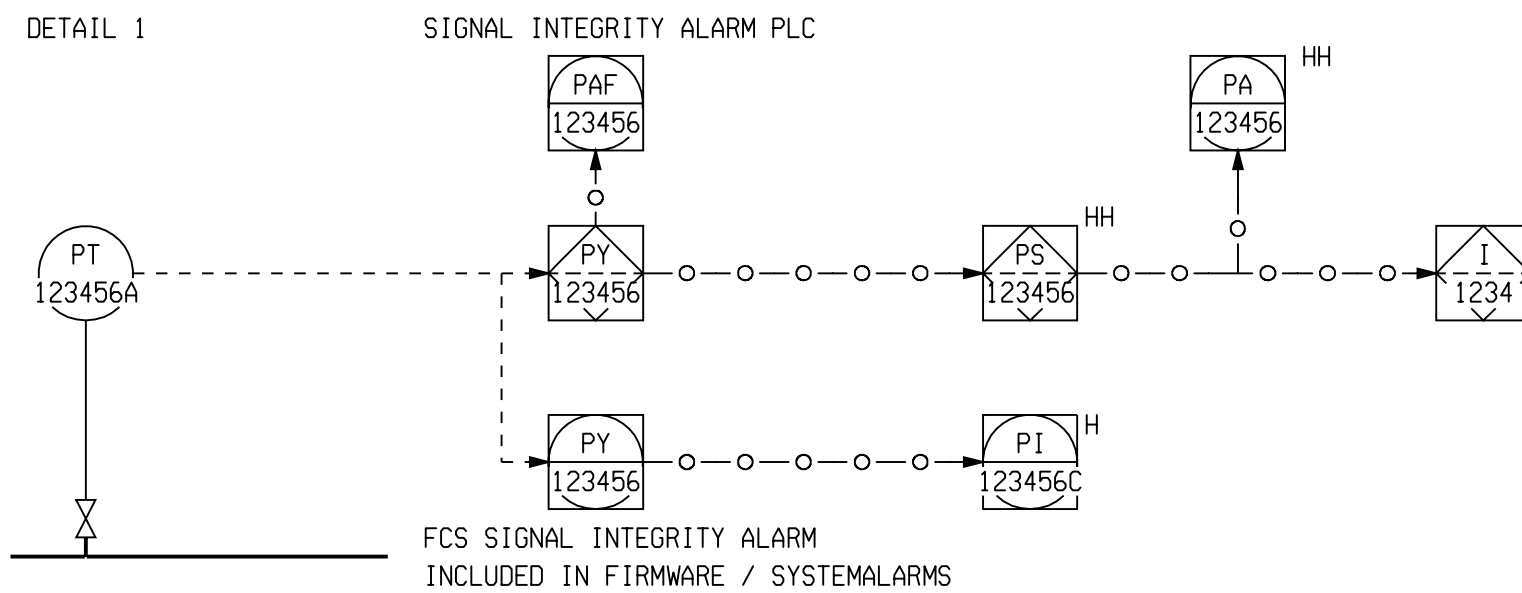

SHORT FORM FOR P&ID DESCRIPTION

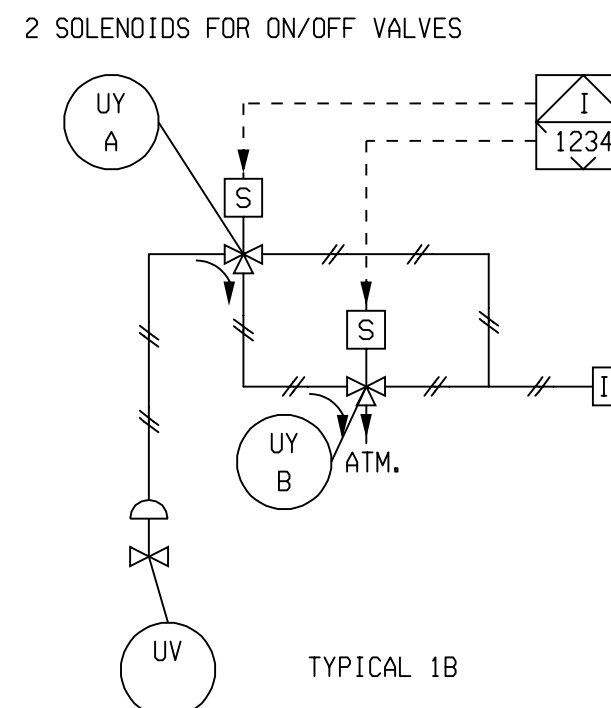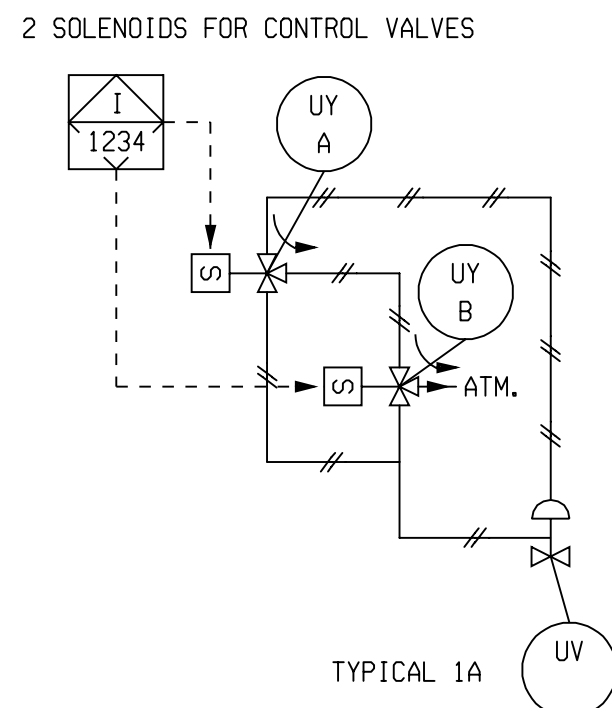

1	VCK	19.03.04	SORG	PTK	22.03.04	AFC	FINAL ISSUE
0	KKP	25.07.02	SPAL	PTK	26.07.02	AFD	FIRST ISSUE
Rev.	LF/PS	Name	Date	Name	Date	Status	Kind of Revision
	Prepared/Changed	Checked		Approved			
Copying of this document, and giving it to others and the use or communication of the contents thereof, are forbidden without express authority by LURQ/PIDEC. Offenders are liable to the payment of damages. All rights are reserved in the event of the grant of a patent or the registration of a utility model or design.							
ZAGROS PETROCHEMICAL COMPANY		NATIONAL PETROCHEMICAL COMPANY شركة پتروشیمی زاگرس زنگنه پتروشیمی					
DISPOSITION		PROJECT : 4th METHANOL PROJECT					
☐ NO COMMENT ☐ COMMENTS AS MARKED. FABRICATION CAN PROCEED ACCORDINGLY. REVISED DOCUMENT TO BE ISSUED EITHER FOR REVIEW OR AS FINAL CERTIFIED. HOWEVER ZAGROS WILL CHECK THIS REVISED DOCUMENT FOR PROPER INCORPORATION. ☐ REJECTED DOCUMENT TO BE REISSUED. ☐ USE FOR INFORMATION ONLY.		OWNER		CONTRACTOR		DWG. NO.	
SIGNATURE		DATE		CONTRACTOR :		Rev. 1	
				PETROCHEMICAL INDUSTRIES DESIGN & ENGINEERING COMPANY شرکت طراحی و مهندسی صنایع پتروشیمی		DIG-PI-004	
ZAGROS REVIEW & COMMENTS DOES NOT ABSOLVE THE VENDOR OF THE RESPONSIBILITY FOR THE CORRECT DESIGN, MANUFACTURING AND OPERATION OF EQUIPMENT.		ZPC PROJ. NO. 40404277		DWG. NO.		Rev.	
		PIDEC PROJ. NO. 1175					
Scales:		Original Size:		engineering Lurgi			
Nominations:		LEGEND INSTRUMENTATION					
Basic documents:		P&I DIAGRAM SHEET 004					
DCC		DG		DL-No.			
Job names:		Lurgi Job No.		Lurgi Document No.		Rev.	
MEGA METHANOL IRAN		I6966601		37104		1	
EDV-Ident-No.:		igs7 e:\pipe\6966601\ru		d.37104.pid 004		25.03.04 VCK IGW61	