




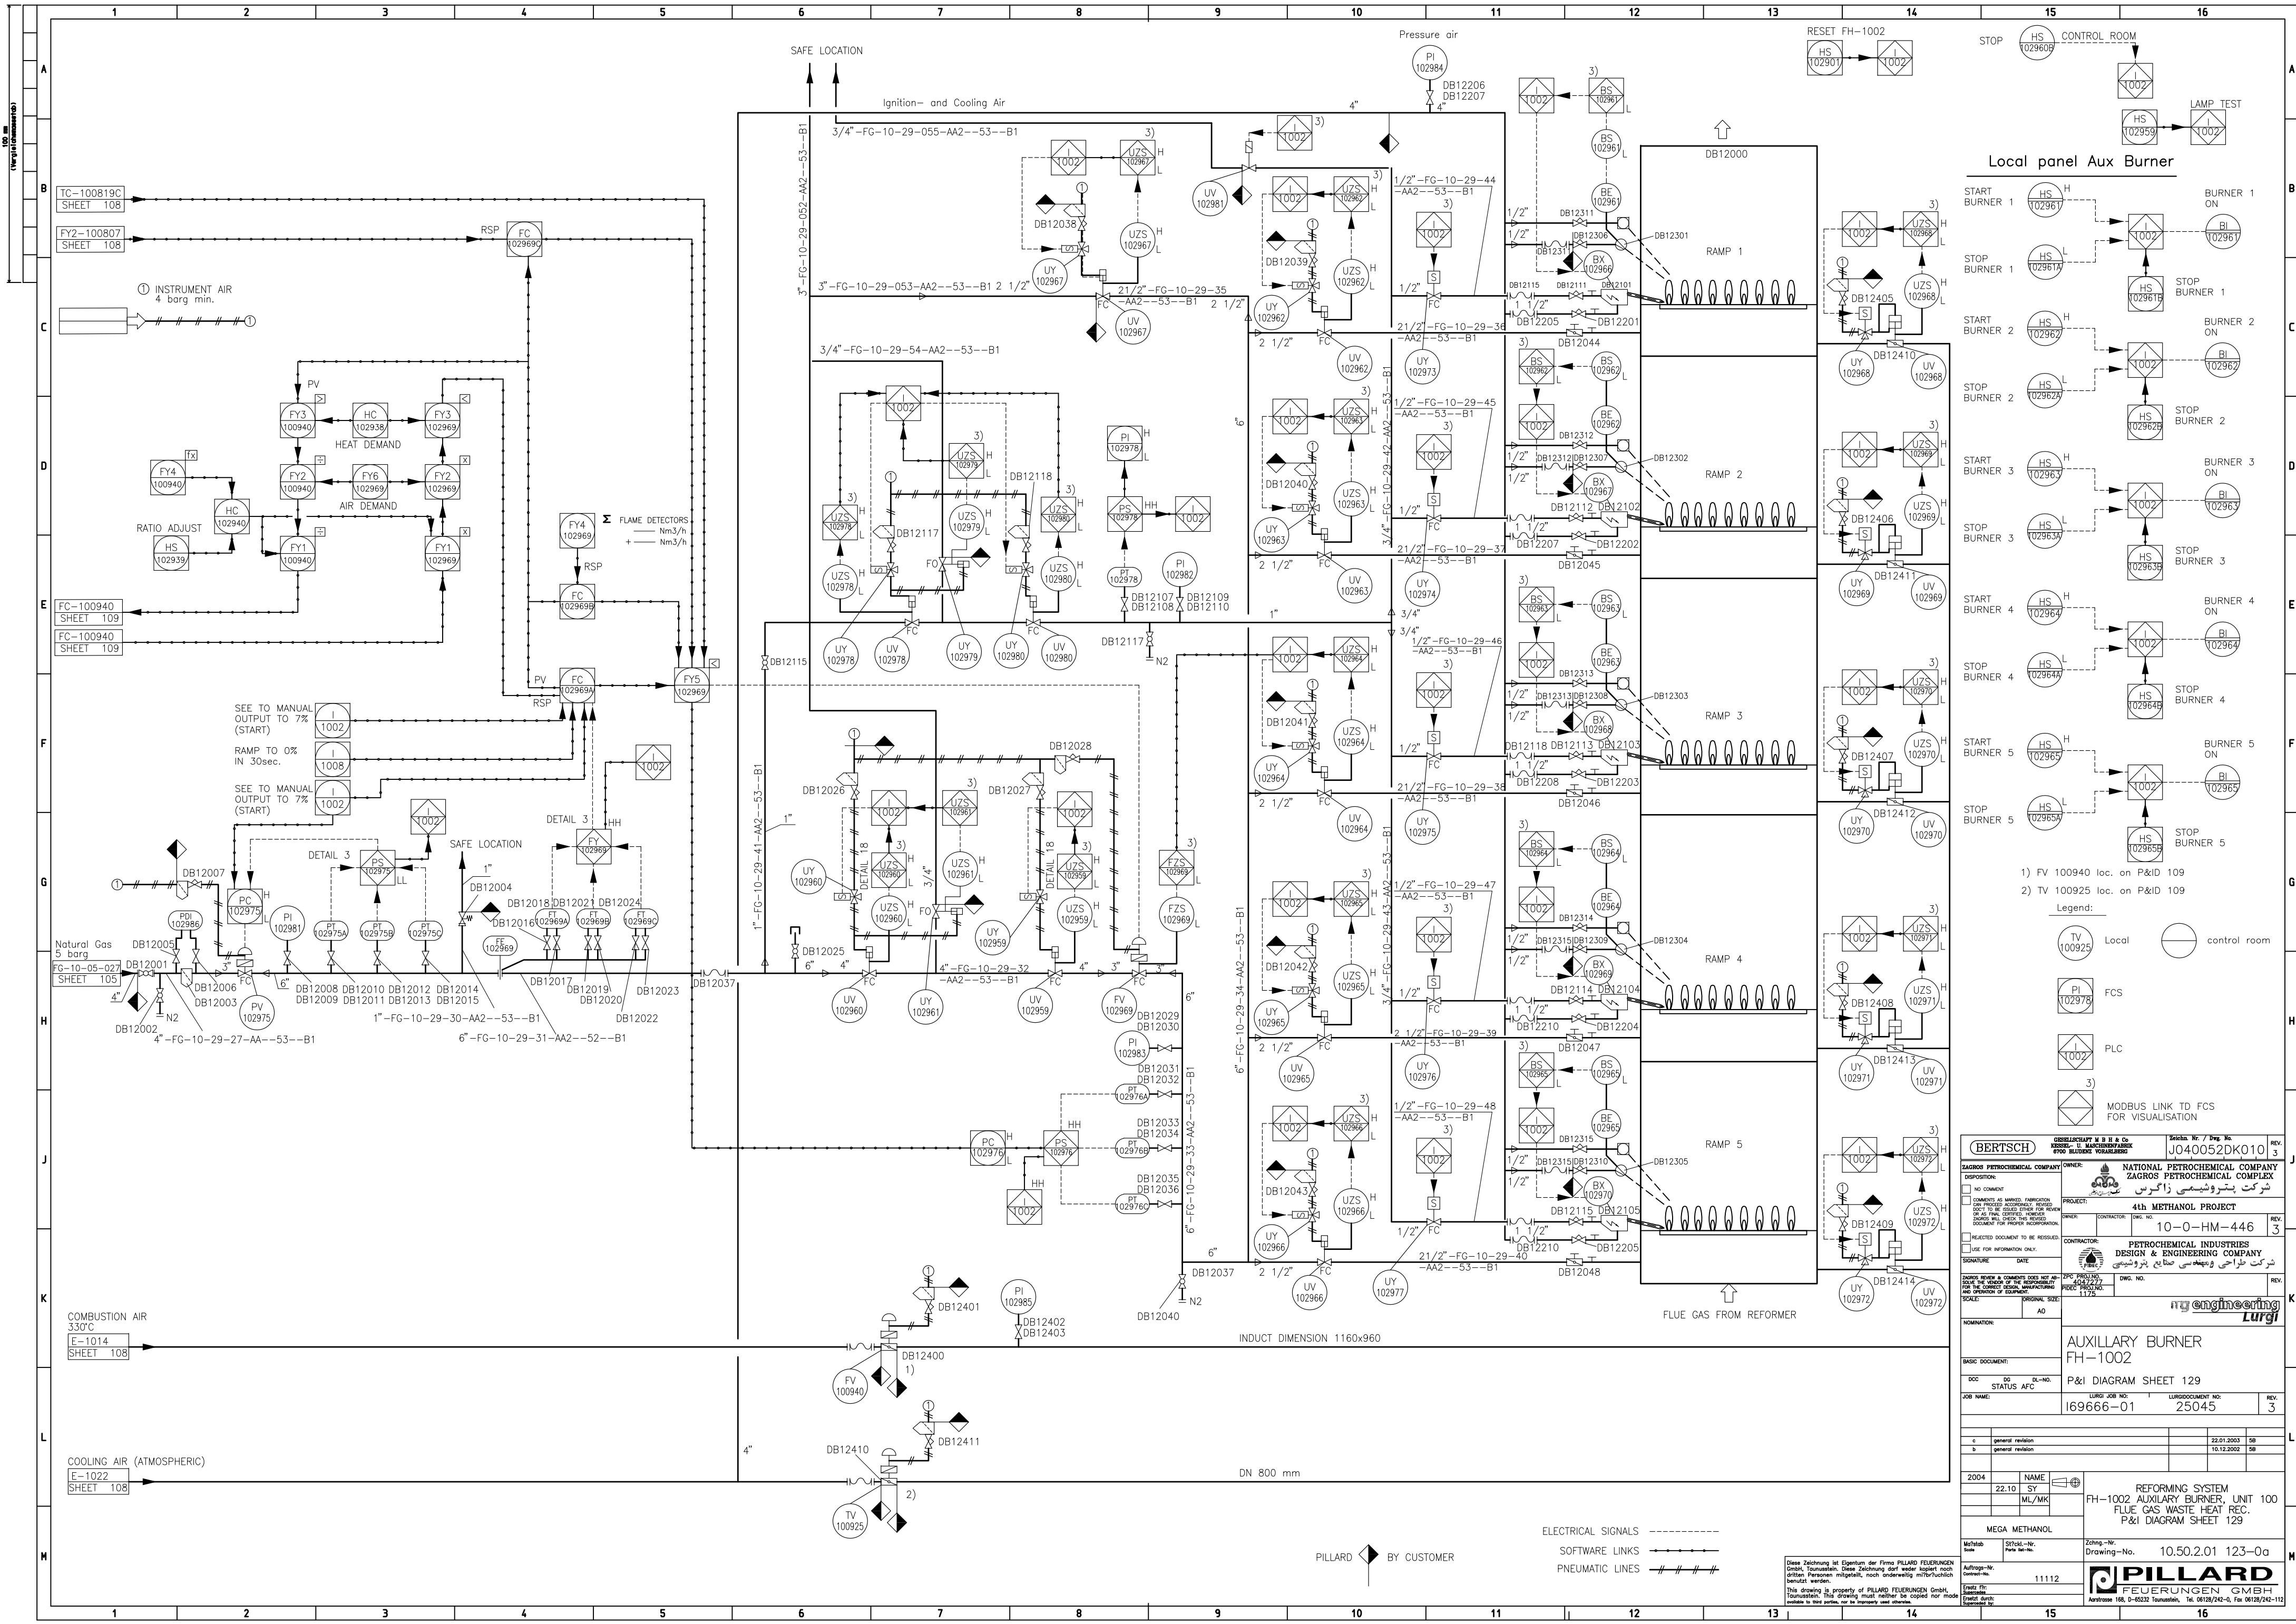

Local panel Aux Burner

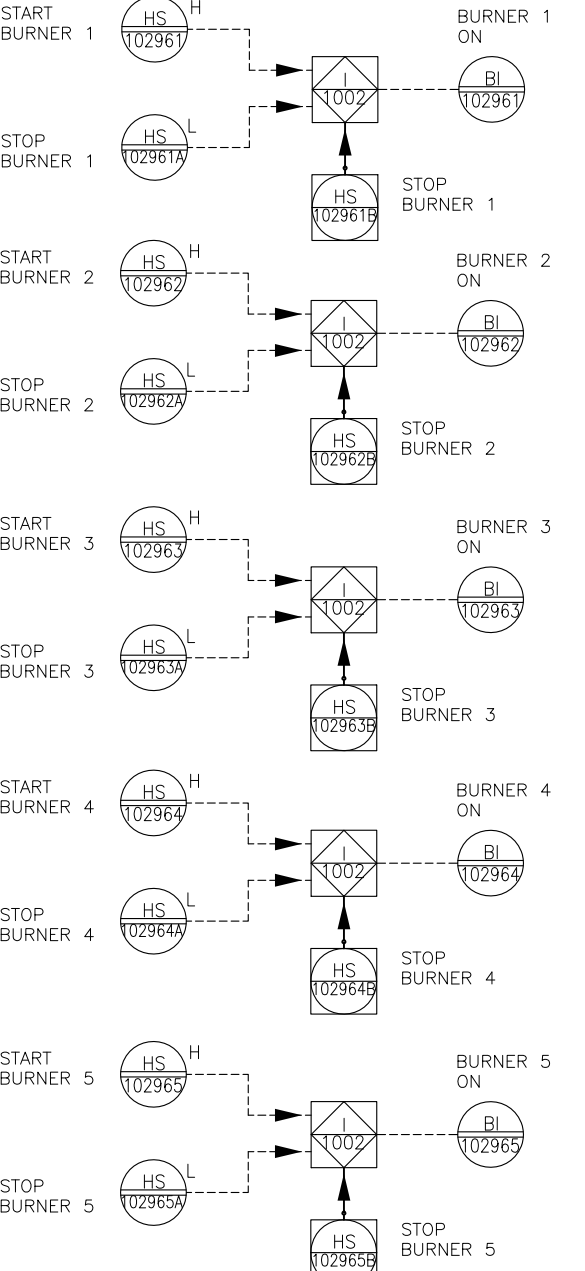

- 1) FV 100940 loc. on P&ID 109
- 2) TV 100925 loc. on P&ID 109

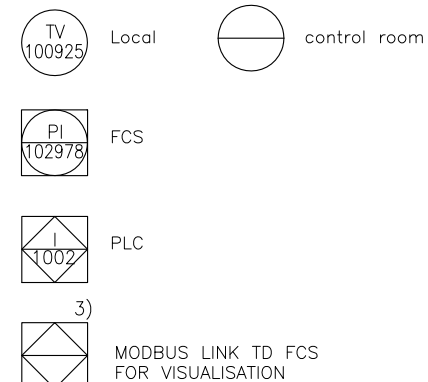

BERTSCH GERÄTEFABRIK M. B. & Co. KOBLENZ, 10. MÄRKTERSTRASSE 57070 BLIESDAHL, VOLKSRING		Zeichn. Nr. / Eng. No. J040052DK010		REV. 3
NATIONAL PETROCHEMICAL COMPANY ZAGROS PETROCHEMICAL COMPLEX شركت پتروشیمی زاگرس		PROJECT: 4th METHANOL PROJECT		REV. 3
CONTRACTOR: PETROCHEMICAL INDUSTRIES DESIGN & ENGINEERING COMPANY شركت طراحی و مهندسی صنایع پتروشیمی		OWNER: 10-0-HM-446		REV. 3
DATE: 11.12.2002		DWG. NO. 11112		REV. 3
NOMINATION: AUXILLARY BURNER FH-1002		STATUS: P&ID DIAGRAM SHEET 129		REV. 3
JOB NAME: 169666-01		UNISUBJECT NO: 25045		REV. 3
c general revision		22.01.2003		58
b general revision		10.12.2002		58
2004		NAME		
22.10		SY		
		ML/MK		
MEGA METHANOL		Zchn.-Nr. Drawing-No.		10.50.2.01 123-0a
Methlab Scale		Auftrags-Nr. Contract-No.		11112
Eigenschaften: This drawing is property of PILLARD FEUERUNGEN GmbH, Tübingen. This drawing must neither be copied nor made available to third parties, nor be temporarily used otherwise.		PILLARD FEUERUNGEN GMBH Kornstraße 168, D-85232 Tübingen, Tel. 0714/242-110		